

ABBREVIATIONS

Table of abbreviations for architectural and engineering terms, including ANCHOR BOLT, ARCHITECTURAL CASEWORK, AIR CONDITION (ED) (ING), and various material and structural notations.

NATIONAL ACCOUNTS QUICK REFERENCE SHEET

Table listing equipment and materials such as AUTOMATIC DOORS, DOCK DOORS, HAND DRYERS, and POWER WALL, along with their respective suppliers and contact information.

GRAPHIC AND MATERIAL INDICATIONS

Table of graphic and material indications, including EARTH, GRAVEL, CONCRETE, GRANITE, STEEL, BRICK, BATT INSUL, RIGID INSULATION, and various elevation and section symbols.

FOOD LION


2110 Executive Drive, Salisbury, NC 28147
telephone: 704.633.8250 | foodlion.com

Food Lion of Retail Business Services, an AHOLD DELHAIZE company

REMODEL STORE #2839

860 PARRIS ISLAND GATEWAY,
BEAUFORT, SC 29906

VICINITY MAP

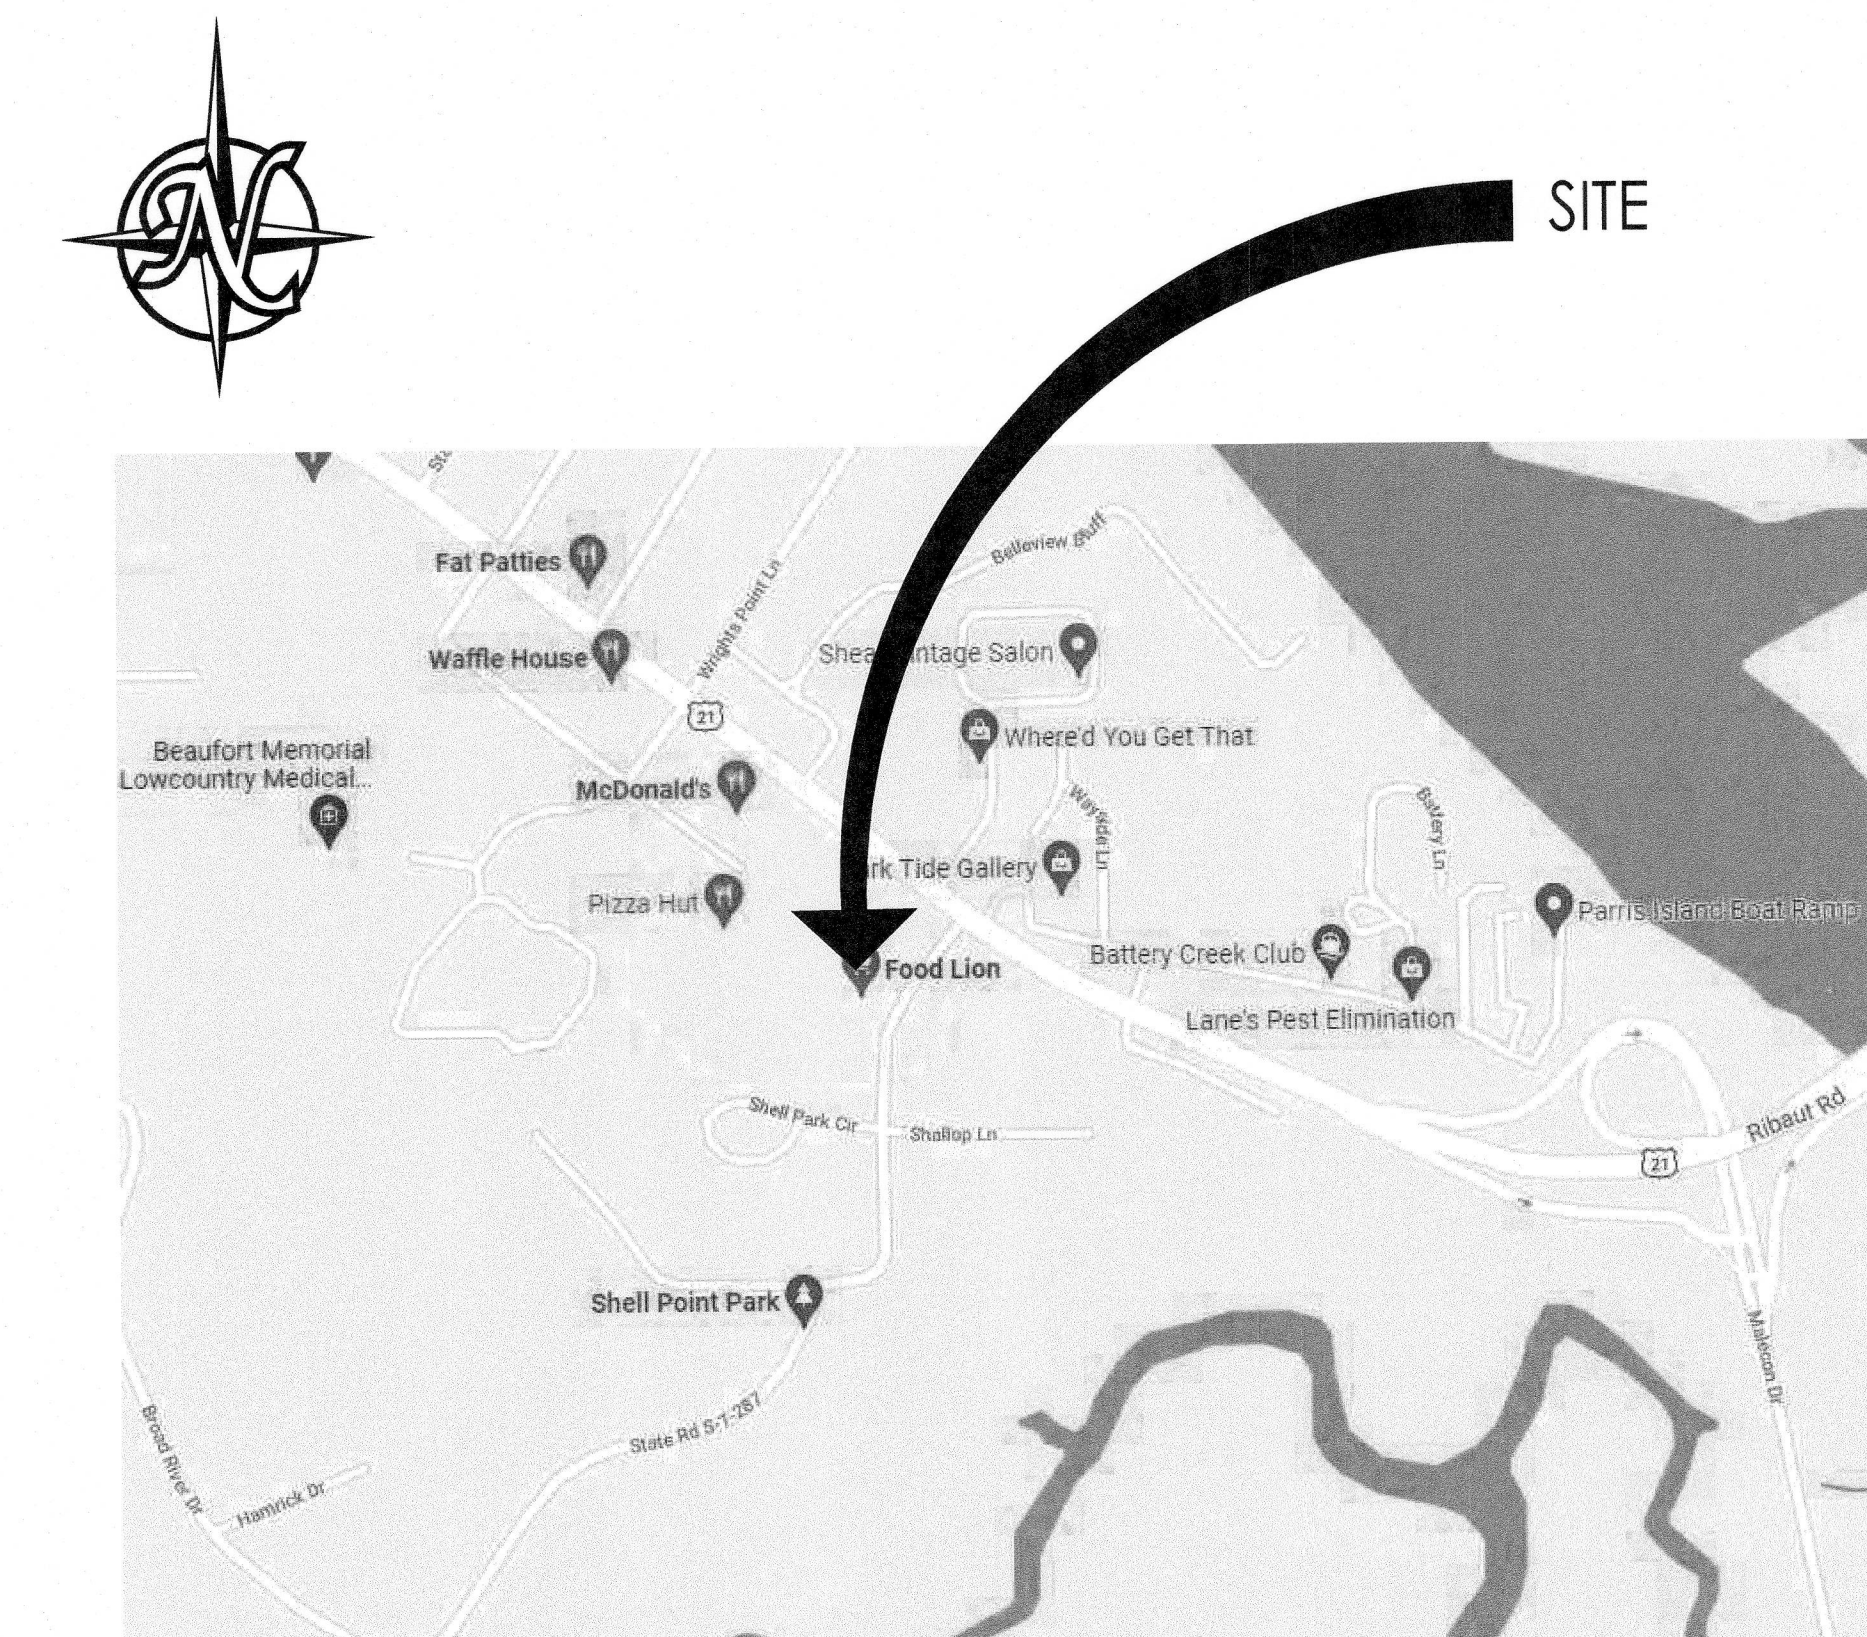

CODE / PROJECT DATA STORE #2839

Table containing building code data, construction classification, area calculations, occupant load, and plumbing fixture calculations.

GOVERNMENTAL AGENCIES

Table listing governmental agencies such as Building Department, Fire Marshal, and Health Department, along with their addresses and contact information.

NOTES:

- List of notes providing instructions for contractors regarding drawing support, questions, and permit requirements.

PROJECT DESCRIPTION

THE PROJECT IS A REMODEL OF EXISTING FOOD LION STORE TO INCLUDE INTERIOR FIXTURE/EQUIPMENT MODIFICATION, MODIFICATIONS TO WALLS OF OFFICE, CUSTOMER SERVICE, MEAT AREA AND/OR DELI-BAKERY, REFINISHING OR FINISH REPLACEMENT OF WALLS, AND FLOORS, REWORK OF PORTIONS OF LIGHTING, ELECTRICAL AND MECHANICAL AS REQUIRED TO ACCOMMODATE FIXTURE/EQUIPMENT MODIFICATIONS, POTENTIAL REPLACEMENT/ ADDITION OF ROOF TOP CONDENSING UNIT FOR REFRIGERATION SYSTEM.

REFERENCE INFORMATION

NOTE: THESE DRAWINGS ARE BASED UPON DRAWINGS AND SCOPE OF WORK PROVIDED BY FOOD LION, EXISTING DRAWINGS ISSUED BY DELTA ENGINEERING, INC 2011, AND A PRELIMINARY SITE/FIELD INVESTIGATION BY INTERPLAN LLC, NOVEMBER 2021.

OWNER & CONSULTANTS

Table listing the owner (Food Lion of Retail Business Services) and various consultants including Electrical Engineer, Architect, Mechanical Engineer, and Structural Engineer.

INDEX OF DRAWINGS


Index of drawings table listing drawing numbers, descriptions, and dates, categorized by Architectural, Structural, Plumbing, Mechanical, and Electrical drawings.

INTERPLAN

Professional seals and logos for Interplan LLC, including the State of South Carolina Registered Architect seal for Orlando, FL.

REVISIONS

Table for recording revisions with columns for NO, DATE, and REMARKS.

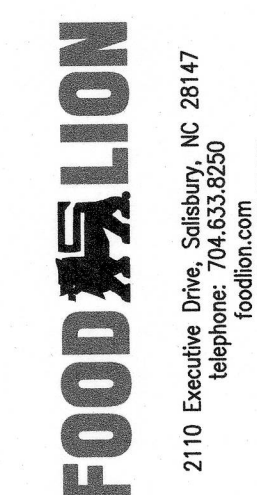

FOOD LION REMODEL STORE #2839
860 PARRIS ISLAND GWY
BEAUFORT, SC 29906

PROJECT NO: 2021.1218

DATE: 7/5/22

1 OF 54
CS-1
COVER SHEET

CHECKED: DNC DRAWN: AI