

REVISIONS	REMARKS
NO DATE	

FOOD LION
2110 Executive Drive, Salisbury, NC 28147
Telephone: 704.633.3950
Food Lion is an AROLD DELAWARE company.

FOOD LION
REMODEL
STORE #2839
860 PARRIS ISLAND GTWY
BEAUFORT, SC 29906


PROJECT NO: 2021.1218
DATE: 7/5/22

48 OF 54
E4.03

CUST. SERV. WORKRM. &
CHECK OUT COMM. PLAN

CHECKED: SN DRAWN: MM

- NOTES:
- ALL CAT 5 CABLE SHALL BE BELDEN 1212 CMR CAT-5E 4 PAIR 24 AWG (BELDEN 1200 DATATWIST CABLE SERIES)
 - ALL CAT 5 CABLE TO BE INSTALLED IN 3/4" CONDUIT UNLESS NOTED OTHERWISE

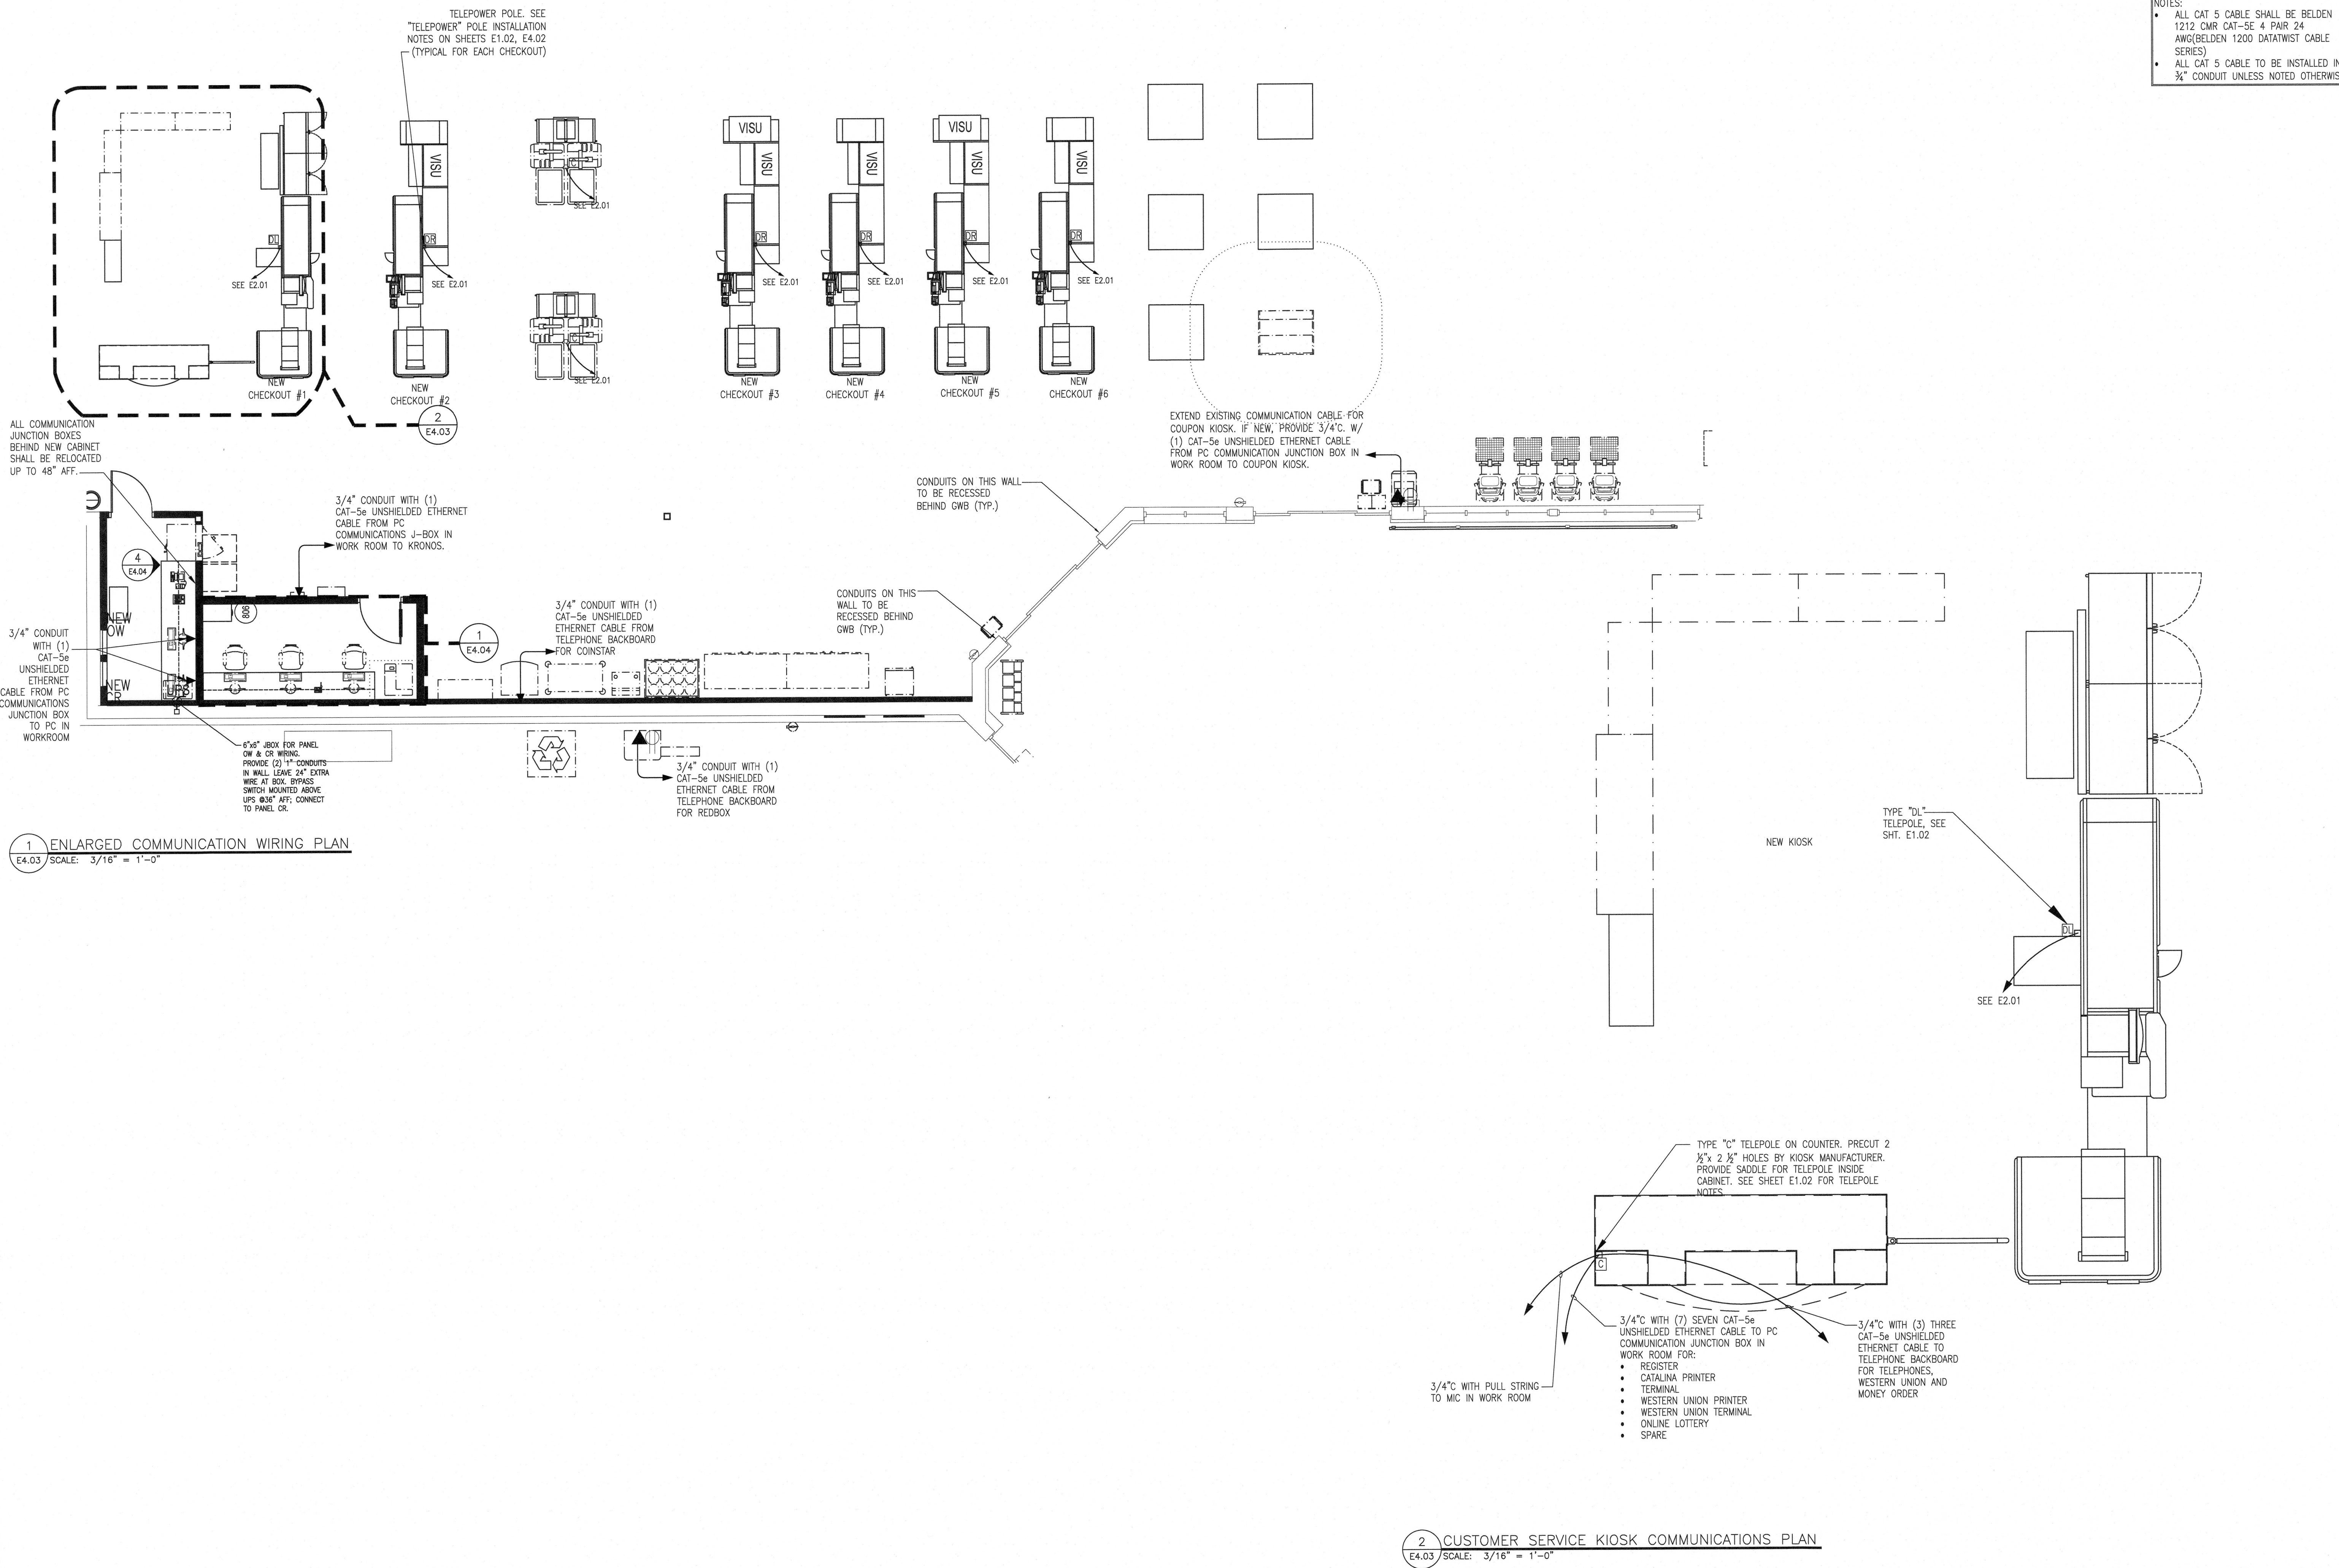

1 ENLARGED COMMUNICATION WIRING PLAN
E4.03 SCALE: 3/16" = 1'-0"

2 CUSTOMER SERVICE KIOSK COMMUNICATIONS PLAN
E4.03 SCALE: 3/16" = 1'-0"

COPYRIGHT © 2022 INTERPLAN, LLC. RESERVES COPYRIGHT & OTHER RIGHTS RESTRICTING THESE DOCUMENTS TO THE ORIGINAL SITE OR PURPOSE FOR WHICH THEY WERE PREPARED. REPRODUCTIONS, REPRODUCTIONS, CHANGES OR ASSIGNMENTS ARE PROHIBITED.