

REVISIONS	NO	DATE	REMARKS

**FOOD LION**  
2110 Executive Drive, Salisbury, NC 28147  
Telephone: 704.633.6250  
Food Lion is an HUNOLD DELHAIZE company.

**FOOD LION**  
REMODEL  
STORE #2839  
860 PARRIS ISLAND GTWY  
BEAUFORT, SC 29906

PROJECT NO: 2021.1218  
DATE: 7/5/22

49 OF 54  
**E4.04**


DEPARTMENT MANAGERS  
OFFICE POWER & COMM.

CHECKED: SN DRAWN: MM


**ELECTRICAL WIRING KEY NOTES**

① VERIFY EXISTING CONDITIONS, CIRCUIT TO BE DEDICATED FED FROM CR PANEL, RE-CIRCUIT AS NECESSARY.


② ROUTE CIRCUITRY UNDER SLAB, CONTRACTOR SHALL STUBUP 2" EC WITH PULLSTRING FOR POWER & DATA. ROUTE UNDERSLAB TO NEAREST HEIGHT WALL AND ROUTR TO UP ABOVE ACCESSIBLE CEILING.

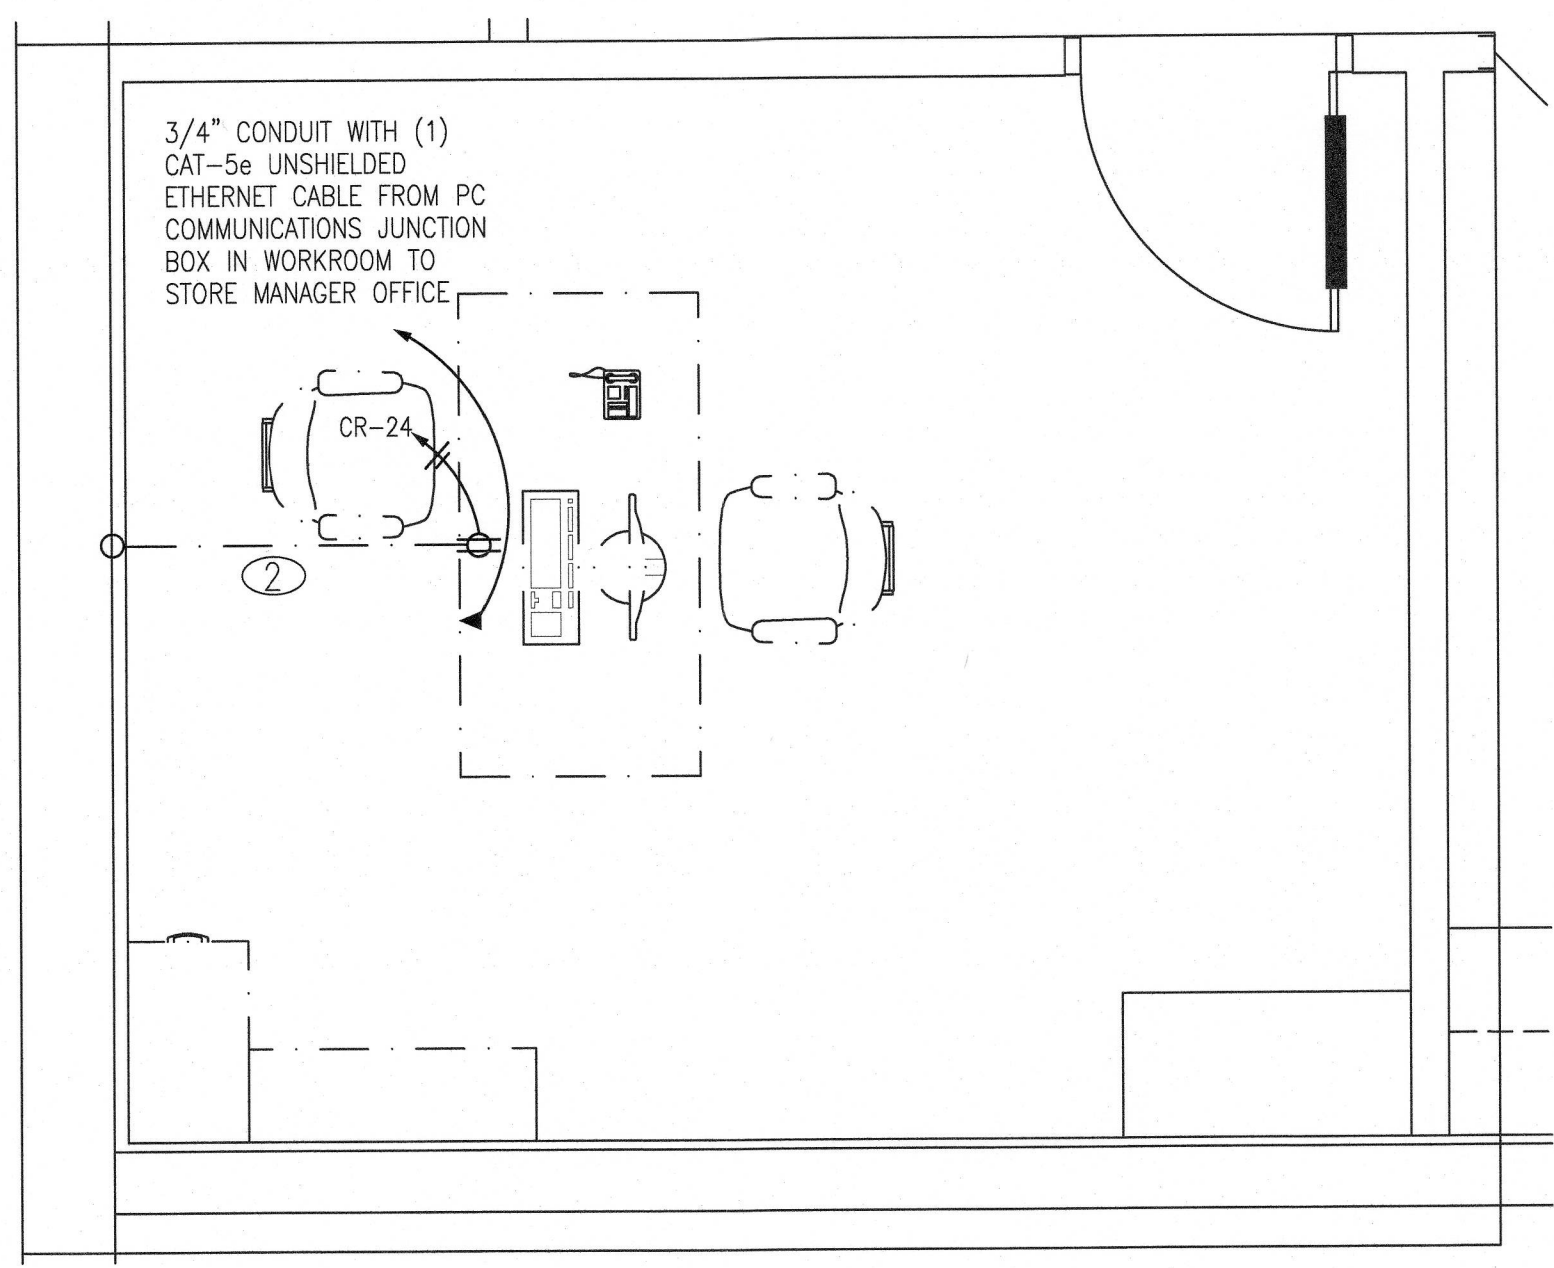


2 ENLARGED ELECTRICAL POWER PLAN - STORE MANAGER OFFICE  
E4.04 SCALE: 1/2" = 1'-0"

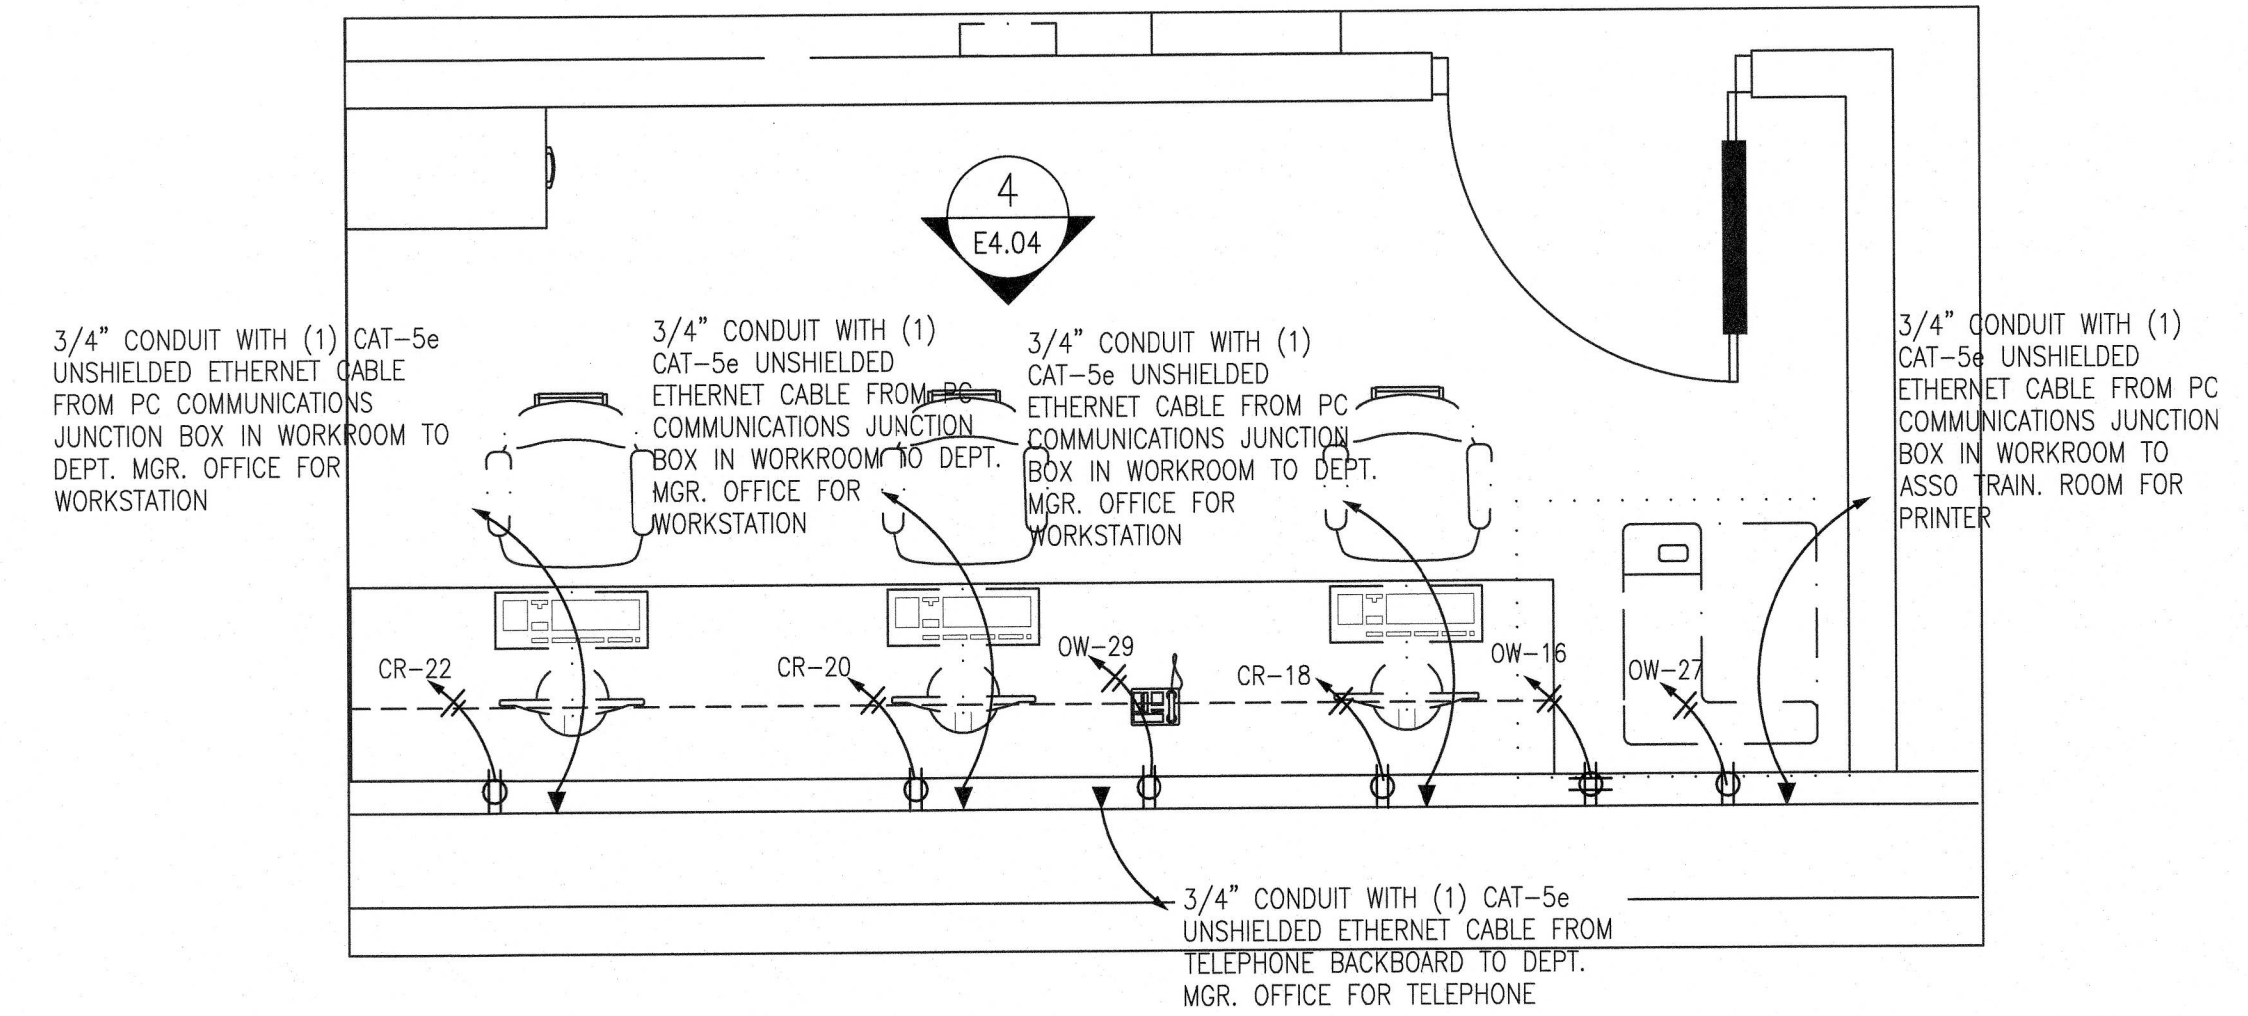

1 ENLARGED ELECTRICAL POWER PLAN - ASSO. TRAIN. ROOM  
E4.04 SCALE: 1/2" = 1'-0"

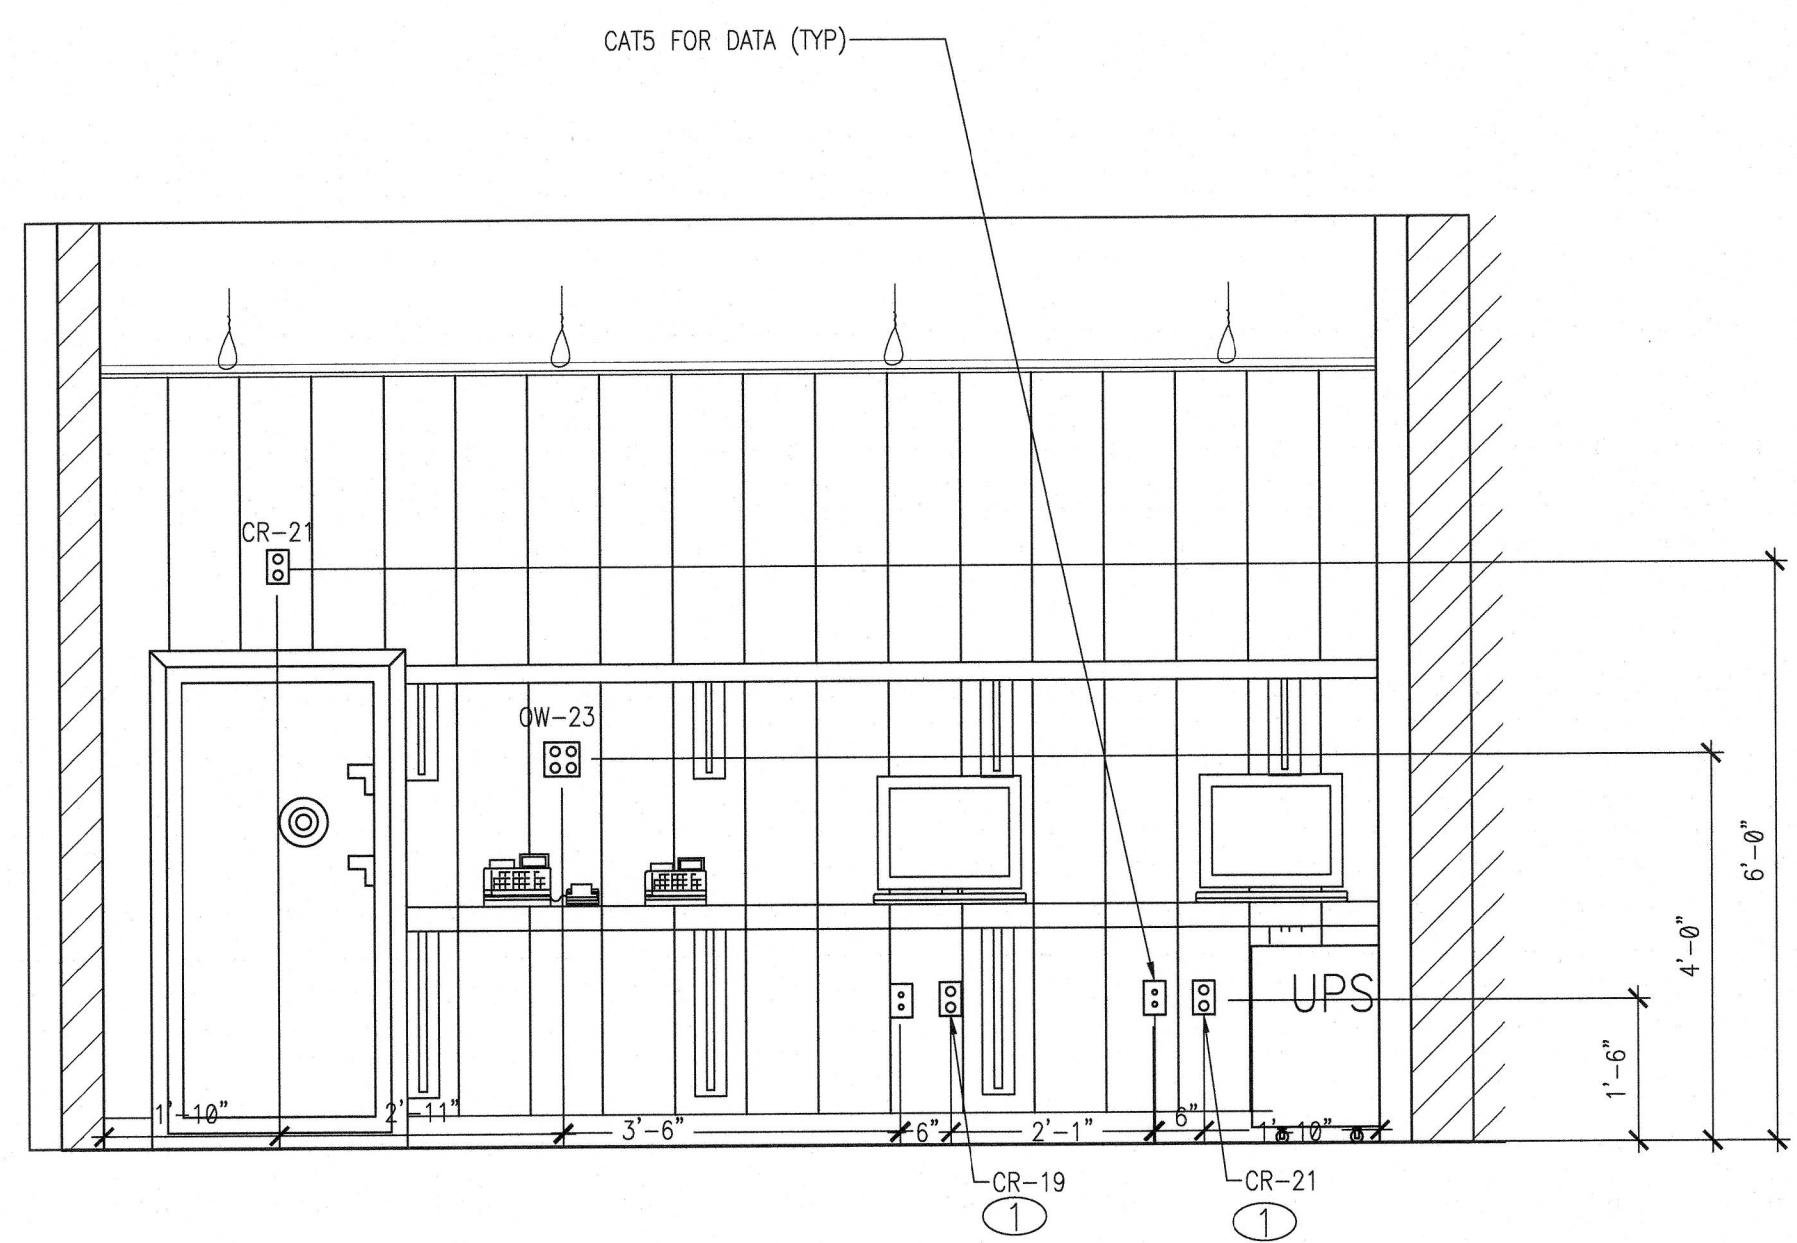

3 NEW WORK ROOM ELEVATION  
E4.04 SCALE: 1/2" = 1'-0"

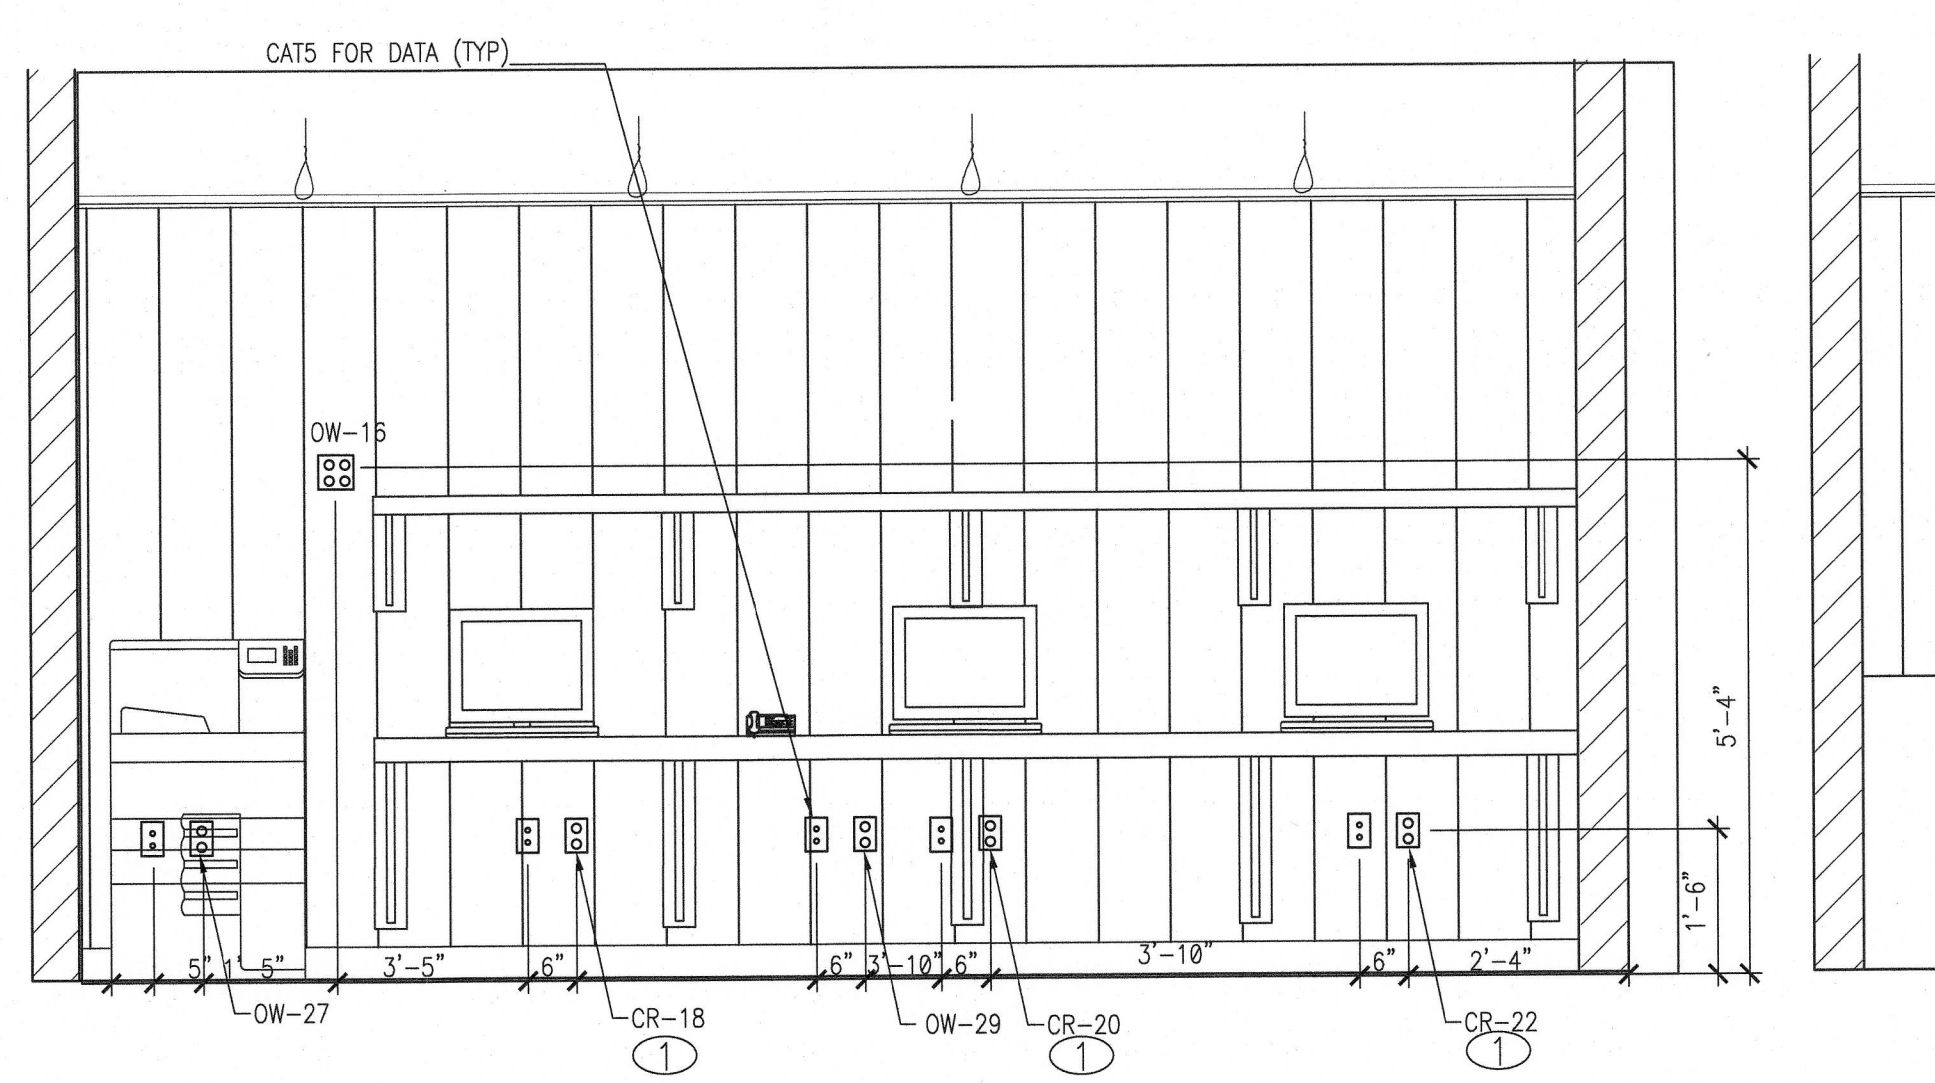

4 NEW DMO/ASSOC TRAIN. ROOM ELEVATION  
E4.04 SCALE: 1/2" = 1'-0"